


LEGEND

 PVMA WATER SERVICE AREA

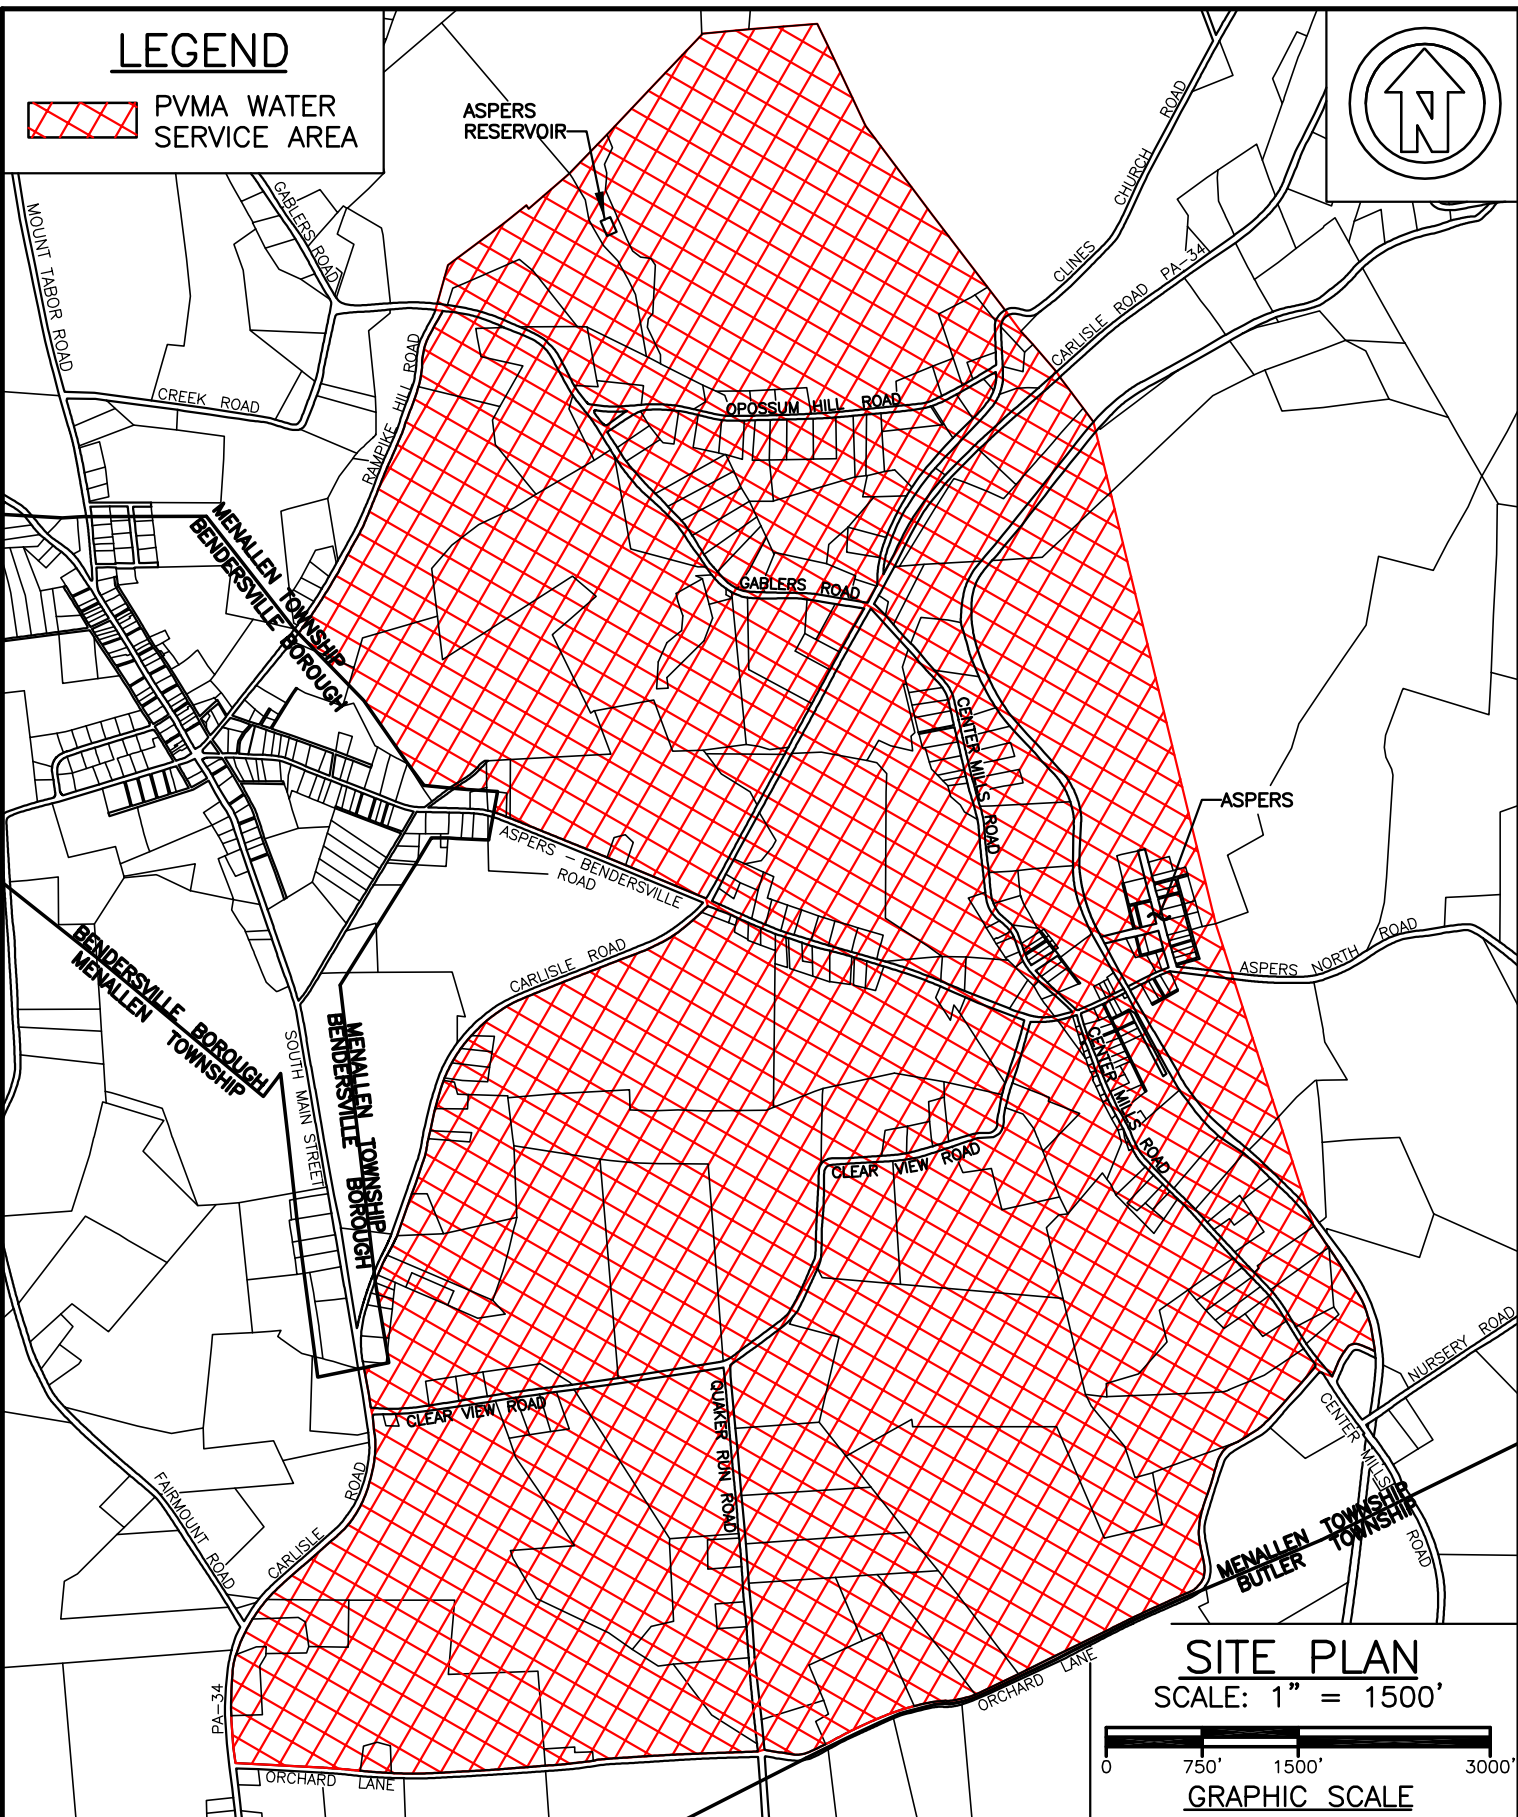

SITE PLAN
SCALE: 1" = 1500'



 **WM. F. HILL & ASSOC., INC.**
PROFESSIONAL ENGINEERS
CIVIL ♦ MUNICIPAL ♦ ENVIRONMENTAL
GETTYSBURG, PA 17325
PH. (717) 334 - 9137

PLAN PREPARATION	
DRAWN BY: BLS	DATE: 1/29/07
DESIGNED BY: BLS	CHECKED BY: WFH

PVMA WATER SERVICE AREA

POSSUM VALLEY MUNICIPAL AUTHORITY
MENALLEN TOWNSHIP, ADAMS COUNTY, PA

SCALE
AS SHOWN

SHEET NO.
1 OF 1